



WASTEWATER FACILITIES BUILDING
SCALE: 1/2" = 1'-0"

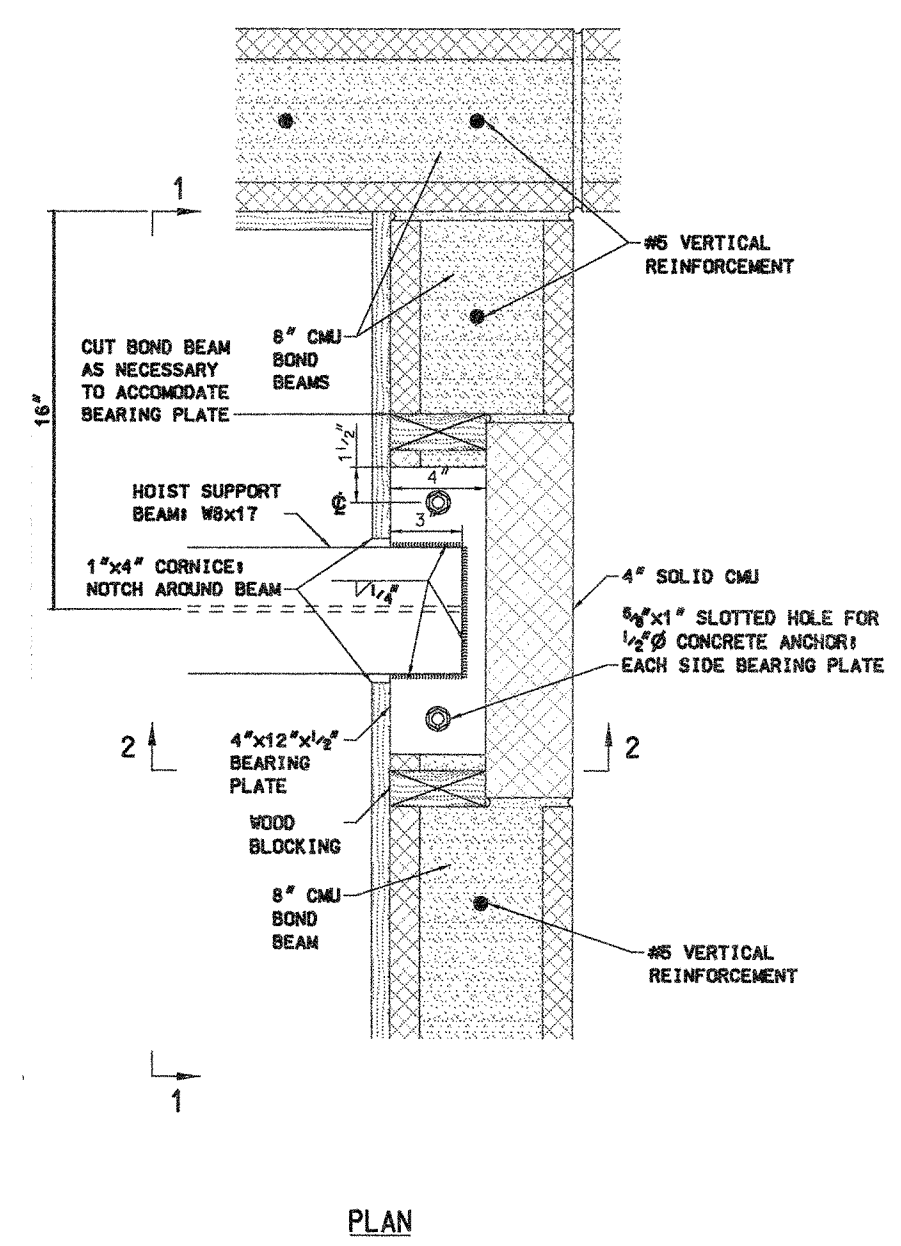


SECTION: 1-1
HOIST BEAM BEARING DETAILS
SCALE: 1 1/2\"/>

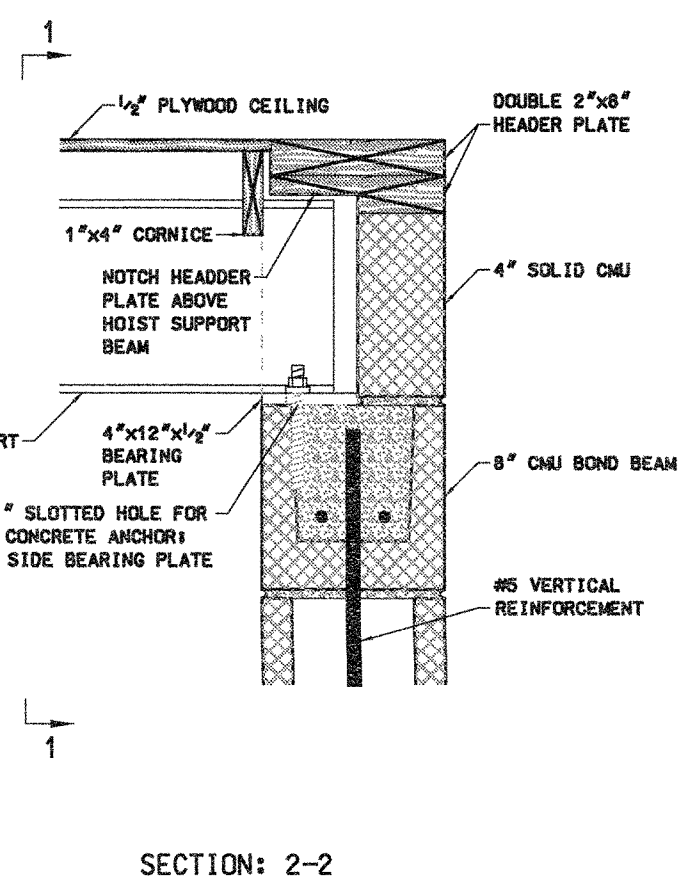

SECTION: 2-2

BERKLEY HOWELL & ASSOC., P.C.
ENGINEERS • SURVEYORS • PLANNERS
306 ENTERPRISE DRIVE, SUITE C
FOREST, VIRGINIA 24551
PHONE: (434)385-7548 FAX: (434)385-6178

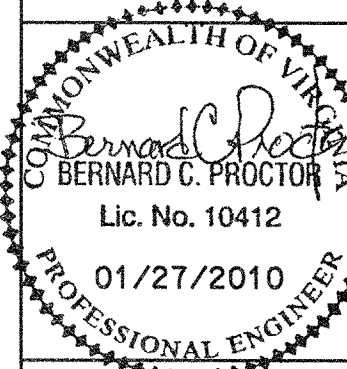

TOWN OF PAMPLIN CITY, VIRGINIA
SANITARY SEWERAGE IMPROVEMENTS

WASTEWATER FACILITIES BUILDING
STRUCTURAL & UNDERGROUND
PIPING PLAN

DATE: 01/27/2010
DRAWN:
CHECKED:

REVISIONS	
NO.	DATE
1	03/12/2010

SCALES
HORIZ: 1/2" = 1'
VERT: 1/2" = 1'
COMM. NO.
030320
SHEET NO.
C.4.40